


1 REFLECTED CEILING PLAN
A-3.01 SCALE 1:100 M.

- CEILING PLAN LEGEND:**
- RECESSED PINLIGHT
 - ▧ 2-20W RECESSED FLOURESCENT FIXTURE
 - LED ROPELIGHT FOR CEILING COVE
 - EXHAUST FAN
 - ⊙ SMOKE / HEAT DETECTOR SENSOR
 - PENDENT SPRINKLER HEAD
 - ▣ CEILING CASSETTE FAN COIL UNIT
 - ▭ WALL MOUNTED FAN COIL UNIT
 - ⊞ AIR COOLED CONDENSING UNIT

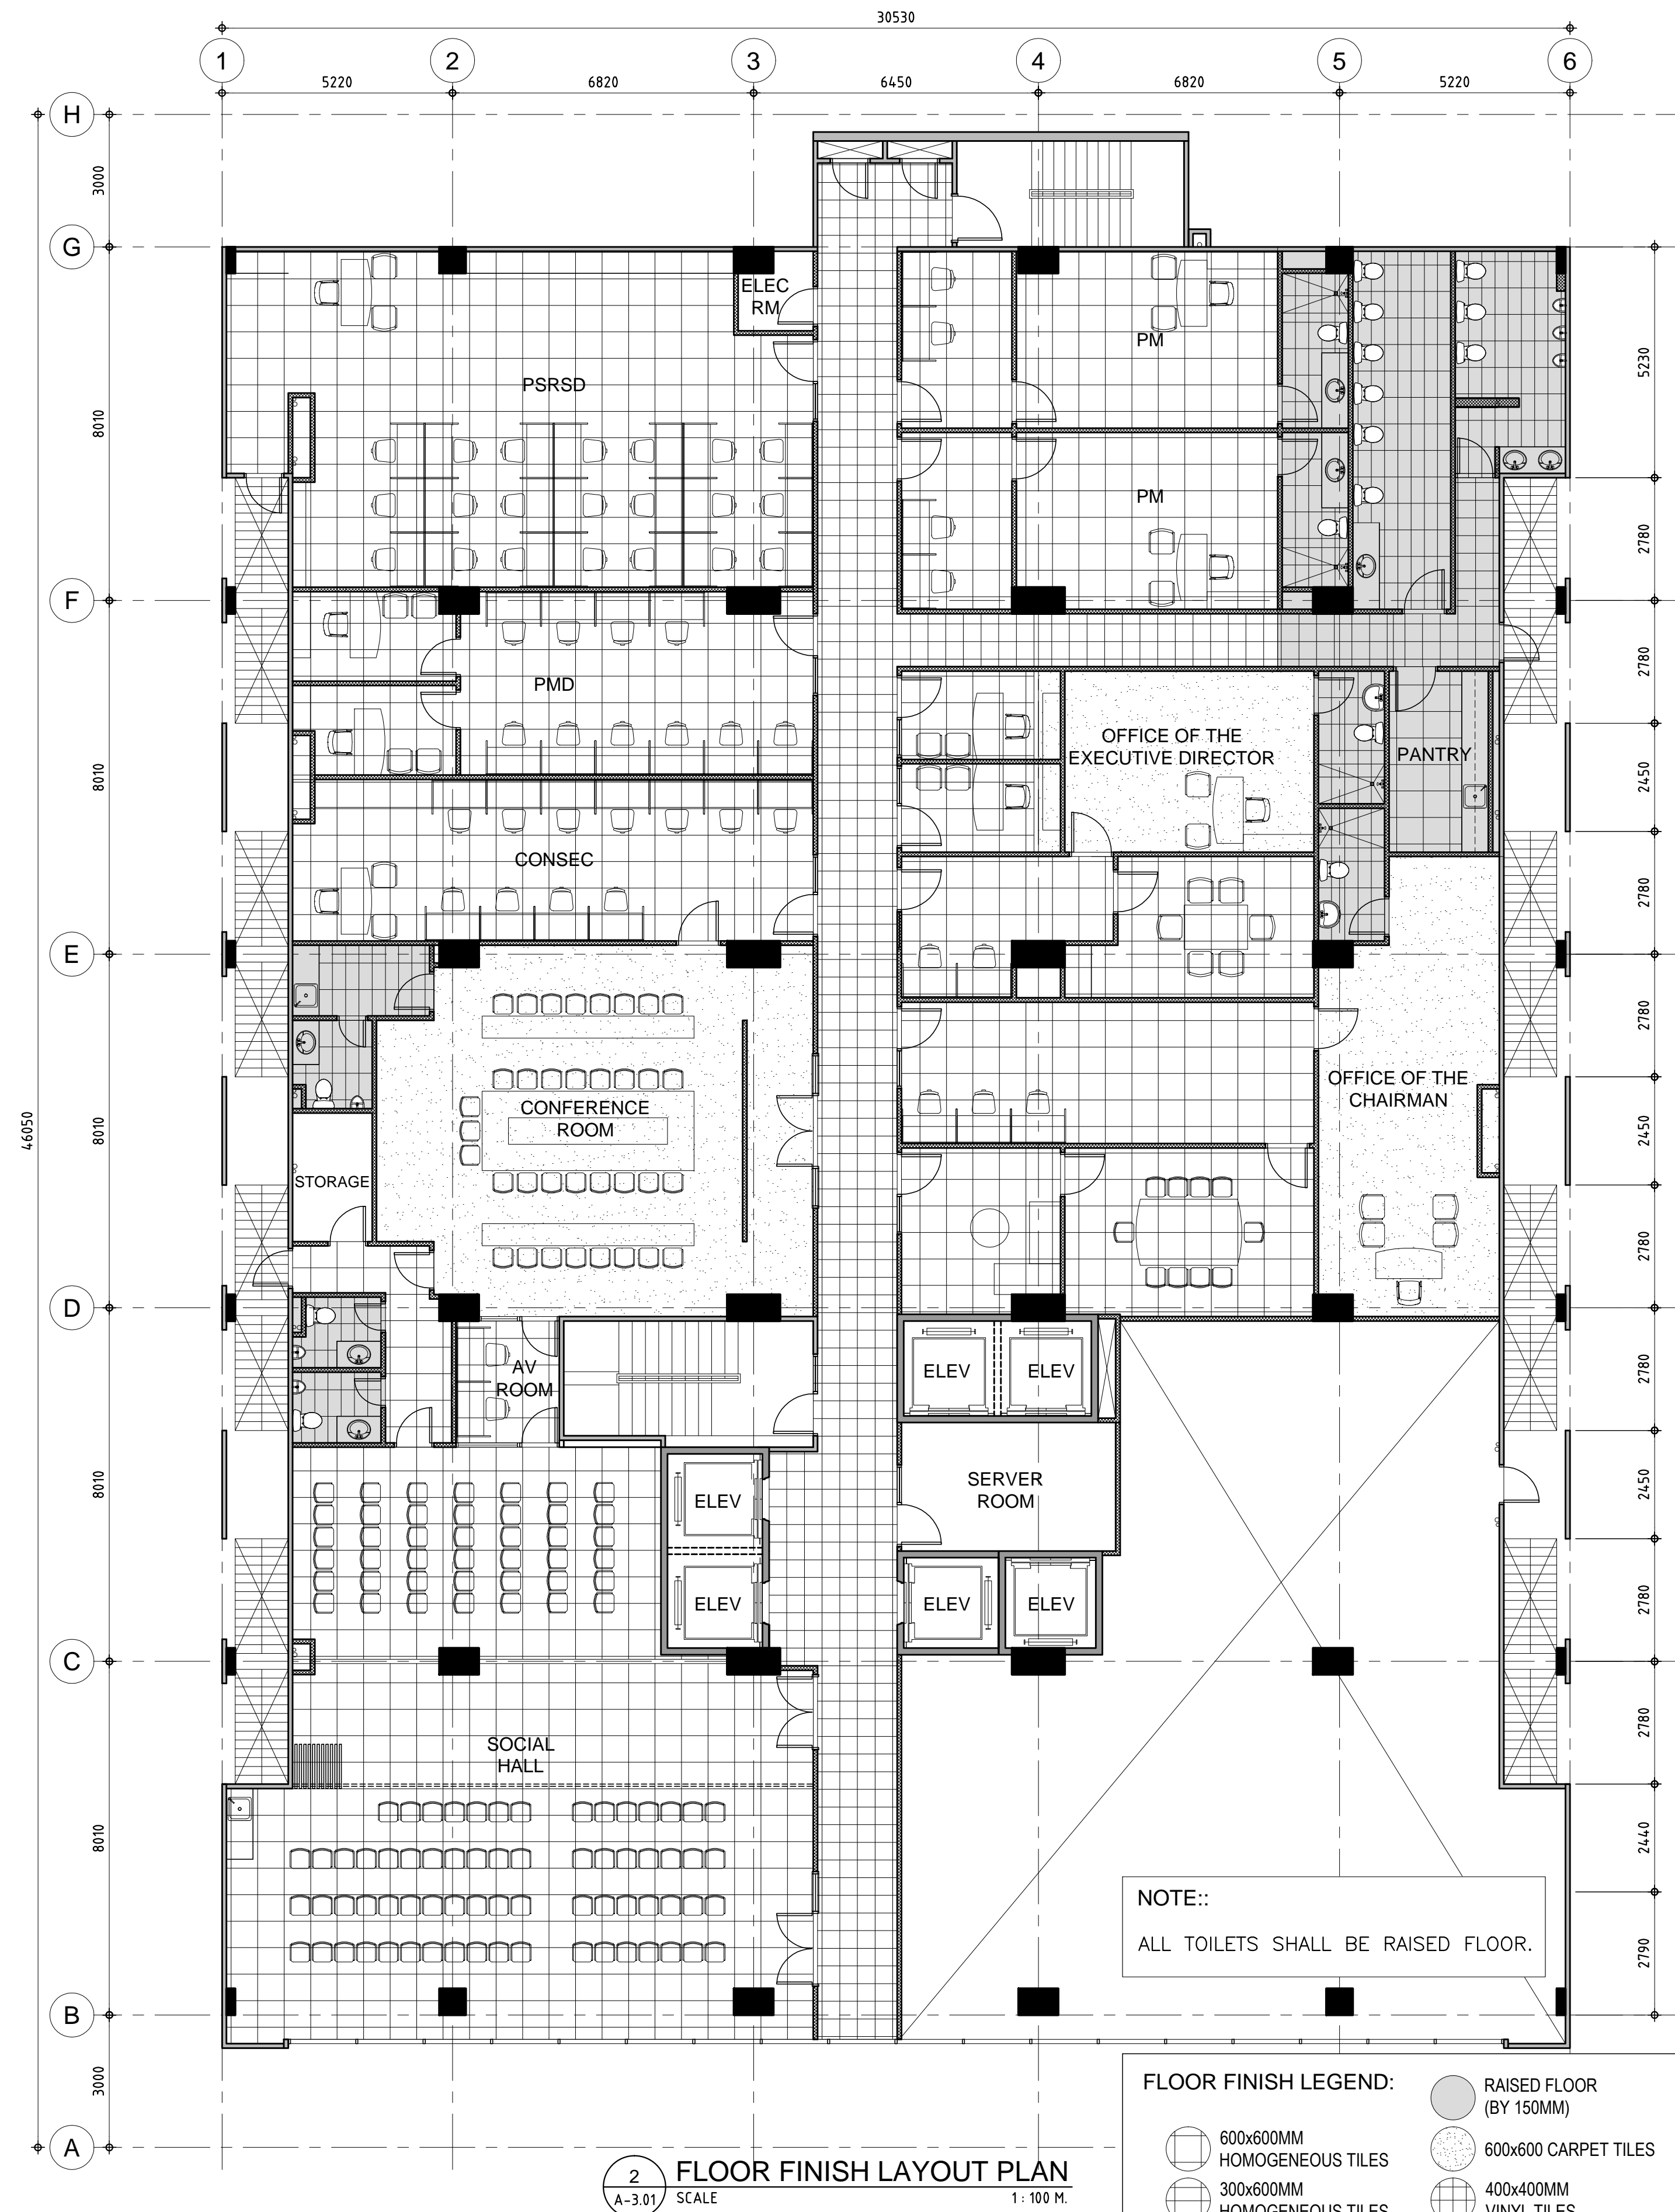

2 FLOOR FINISH LAYOUT PLAN
A-3.01 SCALE 1:100 M.

- FLOOR FINISH LEGEND:**
- RAISED FLOOR (BY 150MM)
 - ▣ 600x600MM HOMOGENEOUS TILES
 - ▧ 600x600 CARPET TILES
 - ▧ 300x600MM HOMOGENEOUS TILES
 - ▧ 400x400MM VINYL TILES

NOTE:
ALL TOILETS SHALL BE RAISED FLOOR.